




NHAM Congress 2022

03-05 JUNE 2022

KUALA LUMPUR CONVENTION CENTRE, Level 3

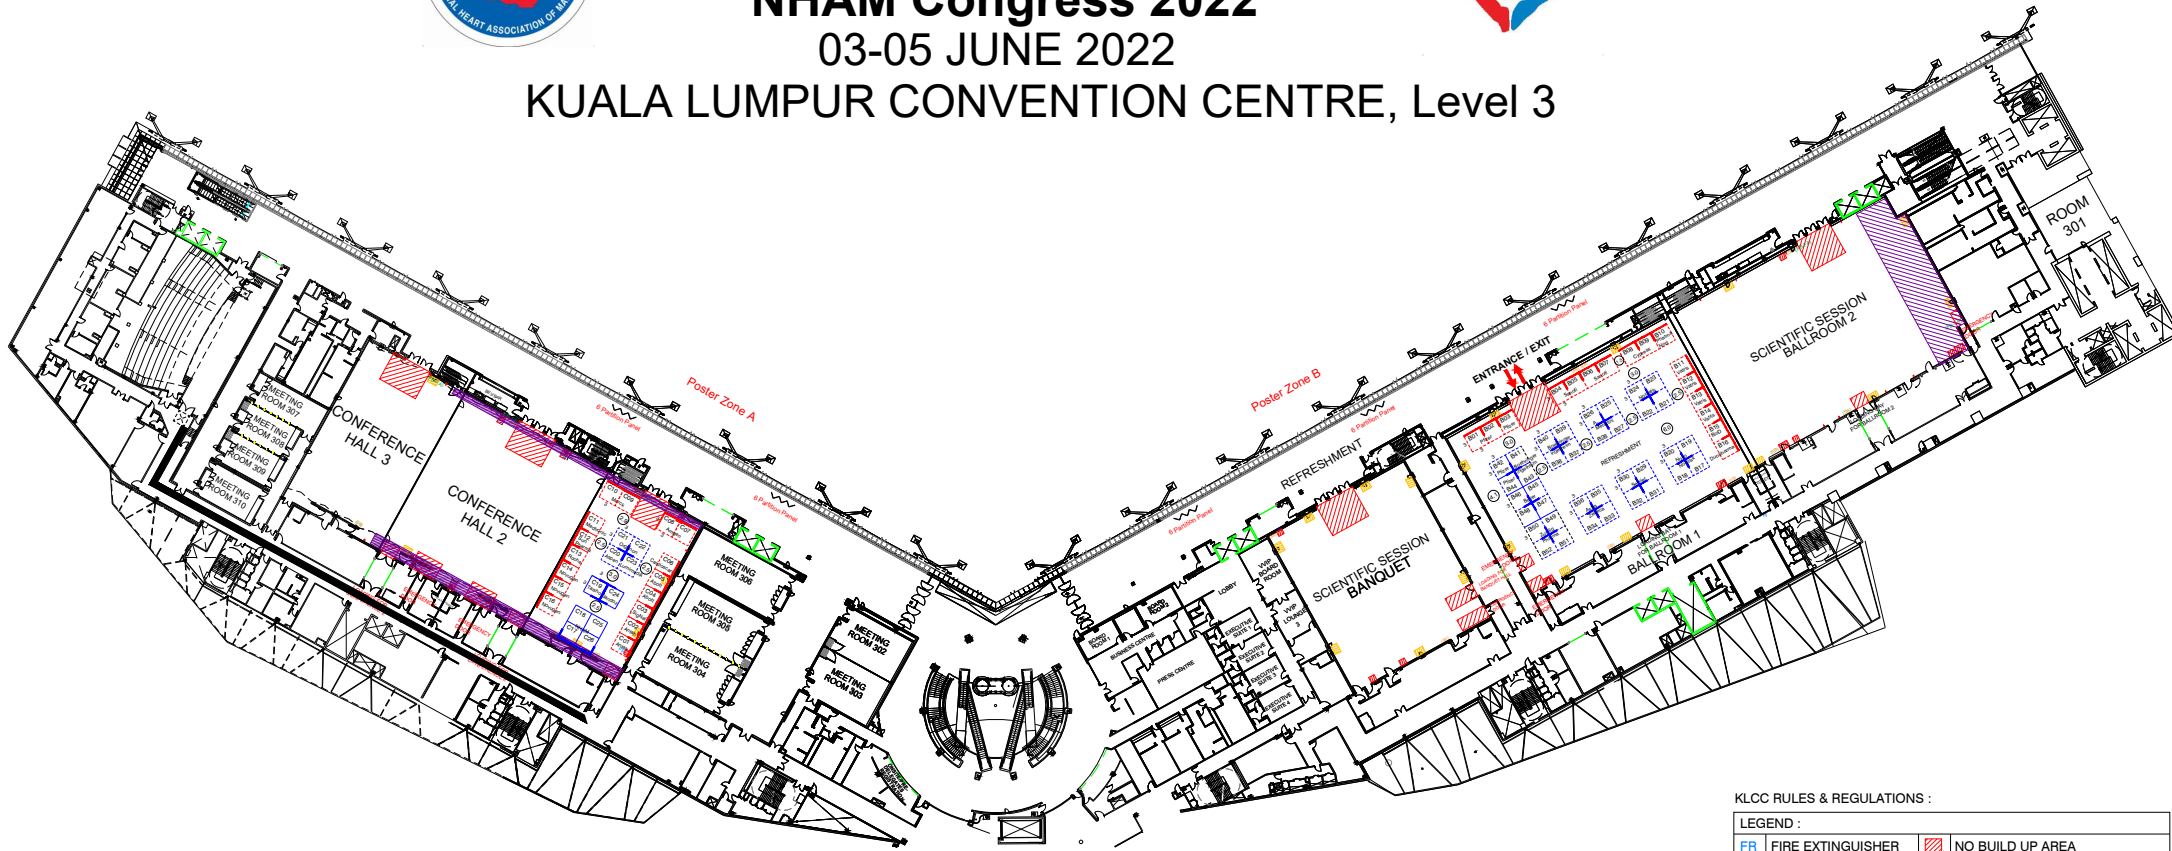

WEST WING

EAST WING

KLCC RULES & REGULATIONS :

LEGEND :				
FR	FIRE EXTINGUISHER		NO BUILD UP AREA	
HR	HOSE REEL		DC	DOOR CONTROLLER
FA	FIRE ALARM		SB	SUIS BOARD
FB	FIRE BREAK GLASS			BALCONY

* THIS FLOOR PLAN IS SUBJECT TO KUALA LUMPUR CONVENTION CENTRE APPROVAL

PROJECT / EXHIBITION / SHOW	SHOW PERIOD	CLIENT	PERSON-IN-CHARGE	REMARKS	AMENDMENT	DATE	DRAWING TITLE
NHAM 2022	3-5 JUNE 2022	EVENT SOLUTION SDN. BHD	SUSAN	-	R00	3.3.2022	LAYOUT PLAN
			SCALE		R01	17.3.2022	
					R02	9.5.2022	
			DRAWN BY		R03	11.5.2022	PROJECT NUMBER
			AZIZ	3.3.2022			-
			CHECKED BY				DRAWING NUMBER
				17.3.2022			EPA/001-OA-R03



This design is copyright of Pico International (M) Sdn Bhd which cannot be reproduced or modified. Any unauthorised use in part or in whole is subject to prosecution.

This drawing is subject to modification to suit construction purposes